



1



2




3



4

KEY PLAN

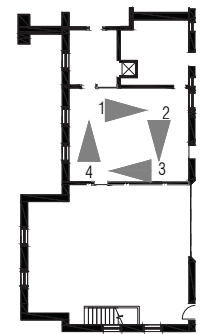



1



2





3



4

KEY PLAN

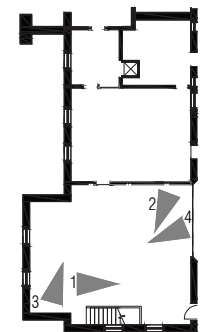

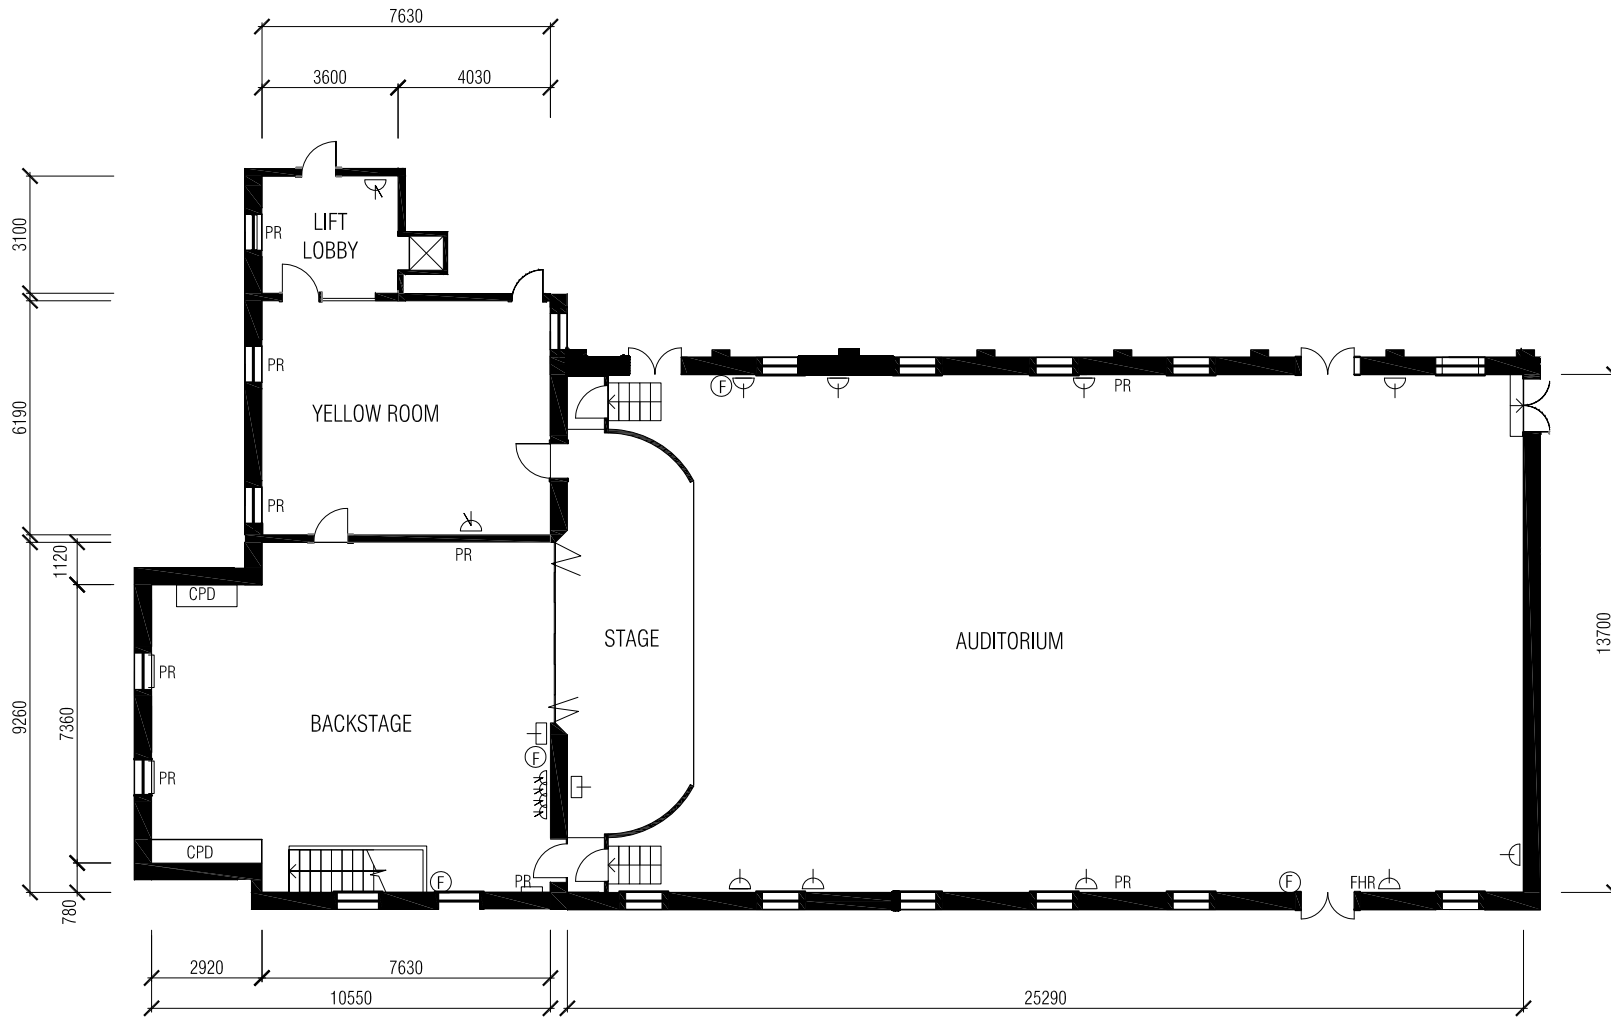


FITTINGS LEGEND

- PR PANEL RADIATOR
- ⊕ FIRE HYDRANT
- FHR FIRE HOSE REEL
- ⏏ SINGLE SOCKET POWER OUTLET
- ⏏ DOUBLE SOCKET POWER OUTLET
- ⏏ 3 PHASE POWER OUTLET


- 4260 CEILING HEIGHT
- 3650 SUSPENDED LIGHTING HEIGHT

KEY PLAN

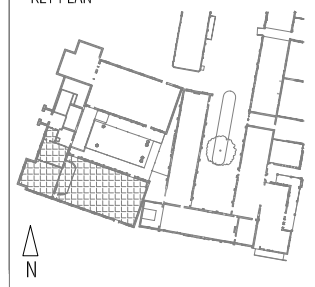

ROSINA AUDITORIUM AND BACKSTAGE PLAN

 
DRAFT




FITTINGS LEGEND

- BEAM
- LIGHT FITTINGS
- DOWNLIGHT

- 4260 CEILING HEIGHT
- 3950 BEAM HEIGHT
- 3650 SUSPENDED LIGHTING HEIGHT

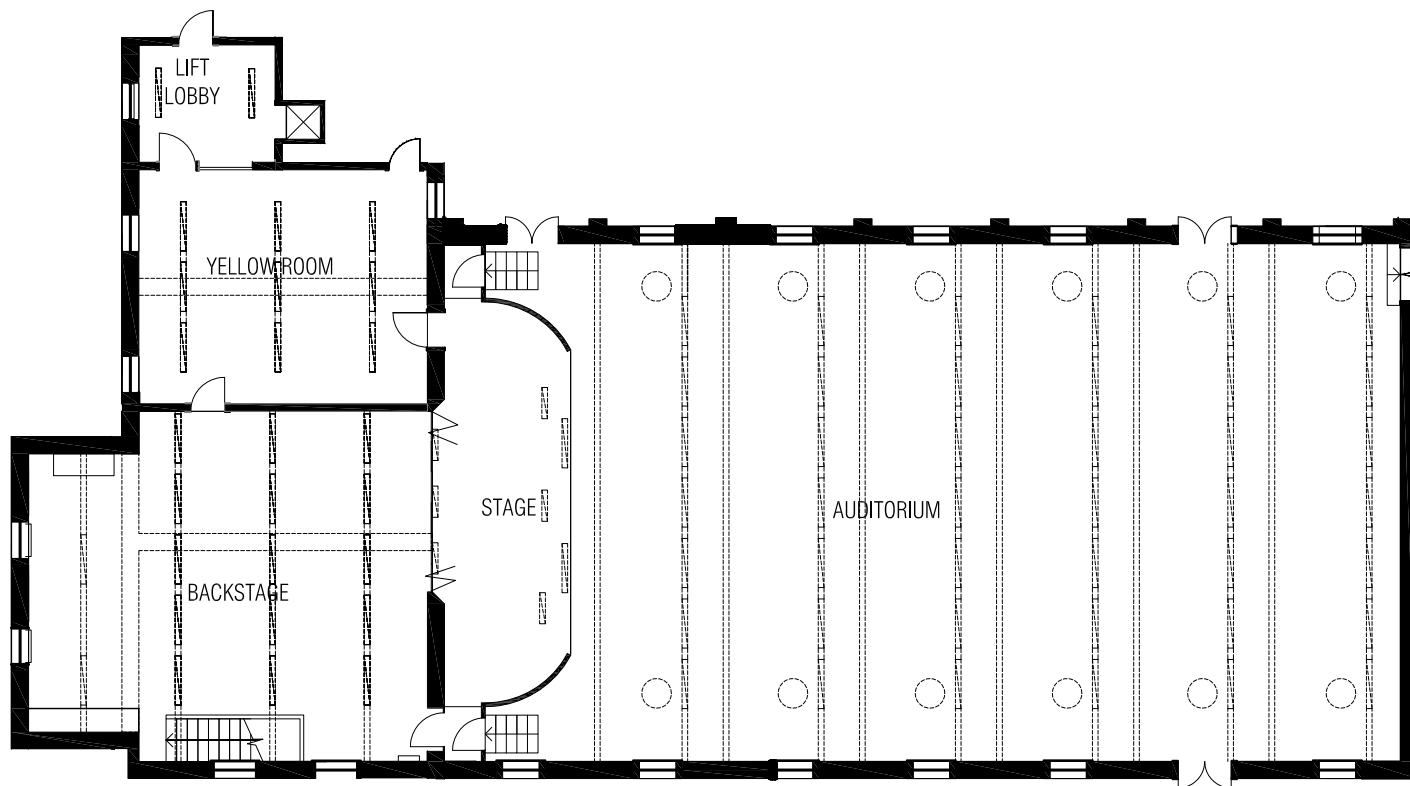

KEY PLAN

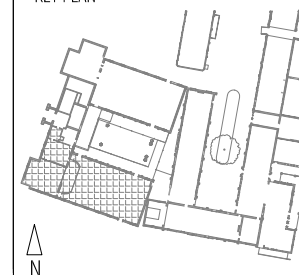


ROSINA AUDITORIUM AND BACKSTAGE REFLECTED CEILING PLAN



Studio 815 / 37 Swanston Street, Melbourne VIC 3000
 t. + 61 (0) 439 767 228 t. + 61 (0) 422 262 847
 we@folkarchitects.com www.folkarchitects.com

 DRAFT



ABBOTSFORD CONVENT ROOM LAYOUT PLANS
 Project No. 1203 Date 11.07.2012

ROSINA BACKSTAGE RCP
 Drawing No. SK007